


BIM 360://FL_00781_Stanford Station FSR (Panama City, FL)P12_SEv2_LRG000781_Stanford Station_P12_SE_ARC_v2_18.01.rvt
5/7/2018 4:47:03 PM
00781-A-100.1-ARCHITECTURAL SITE PLAN - F2F

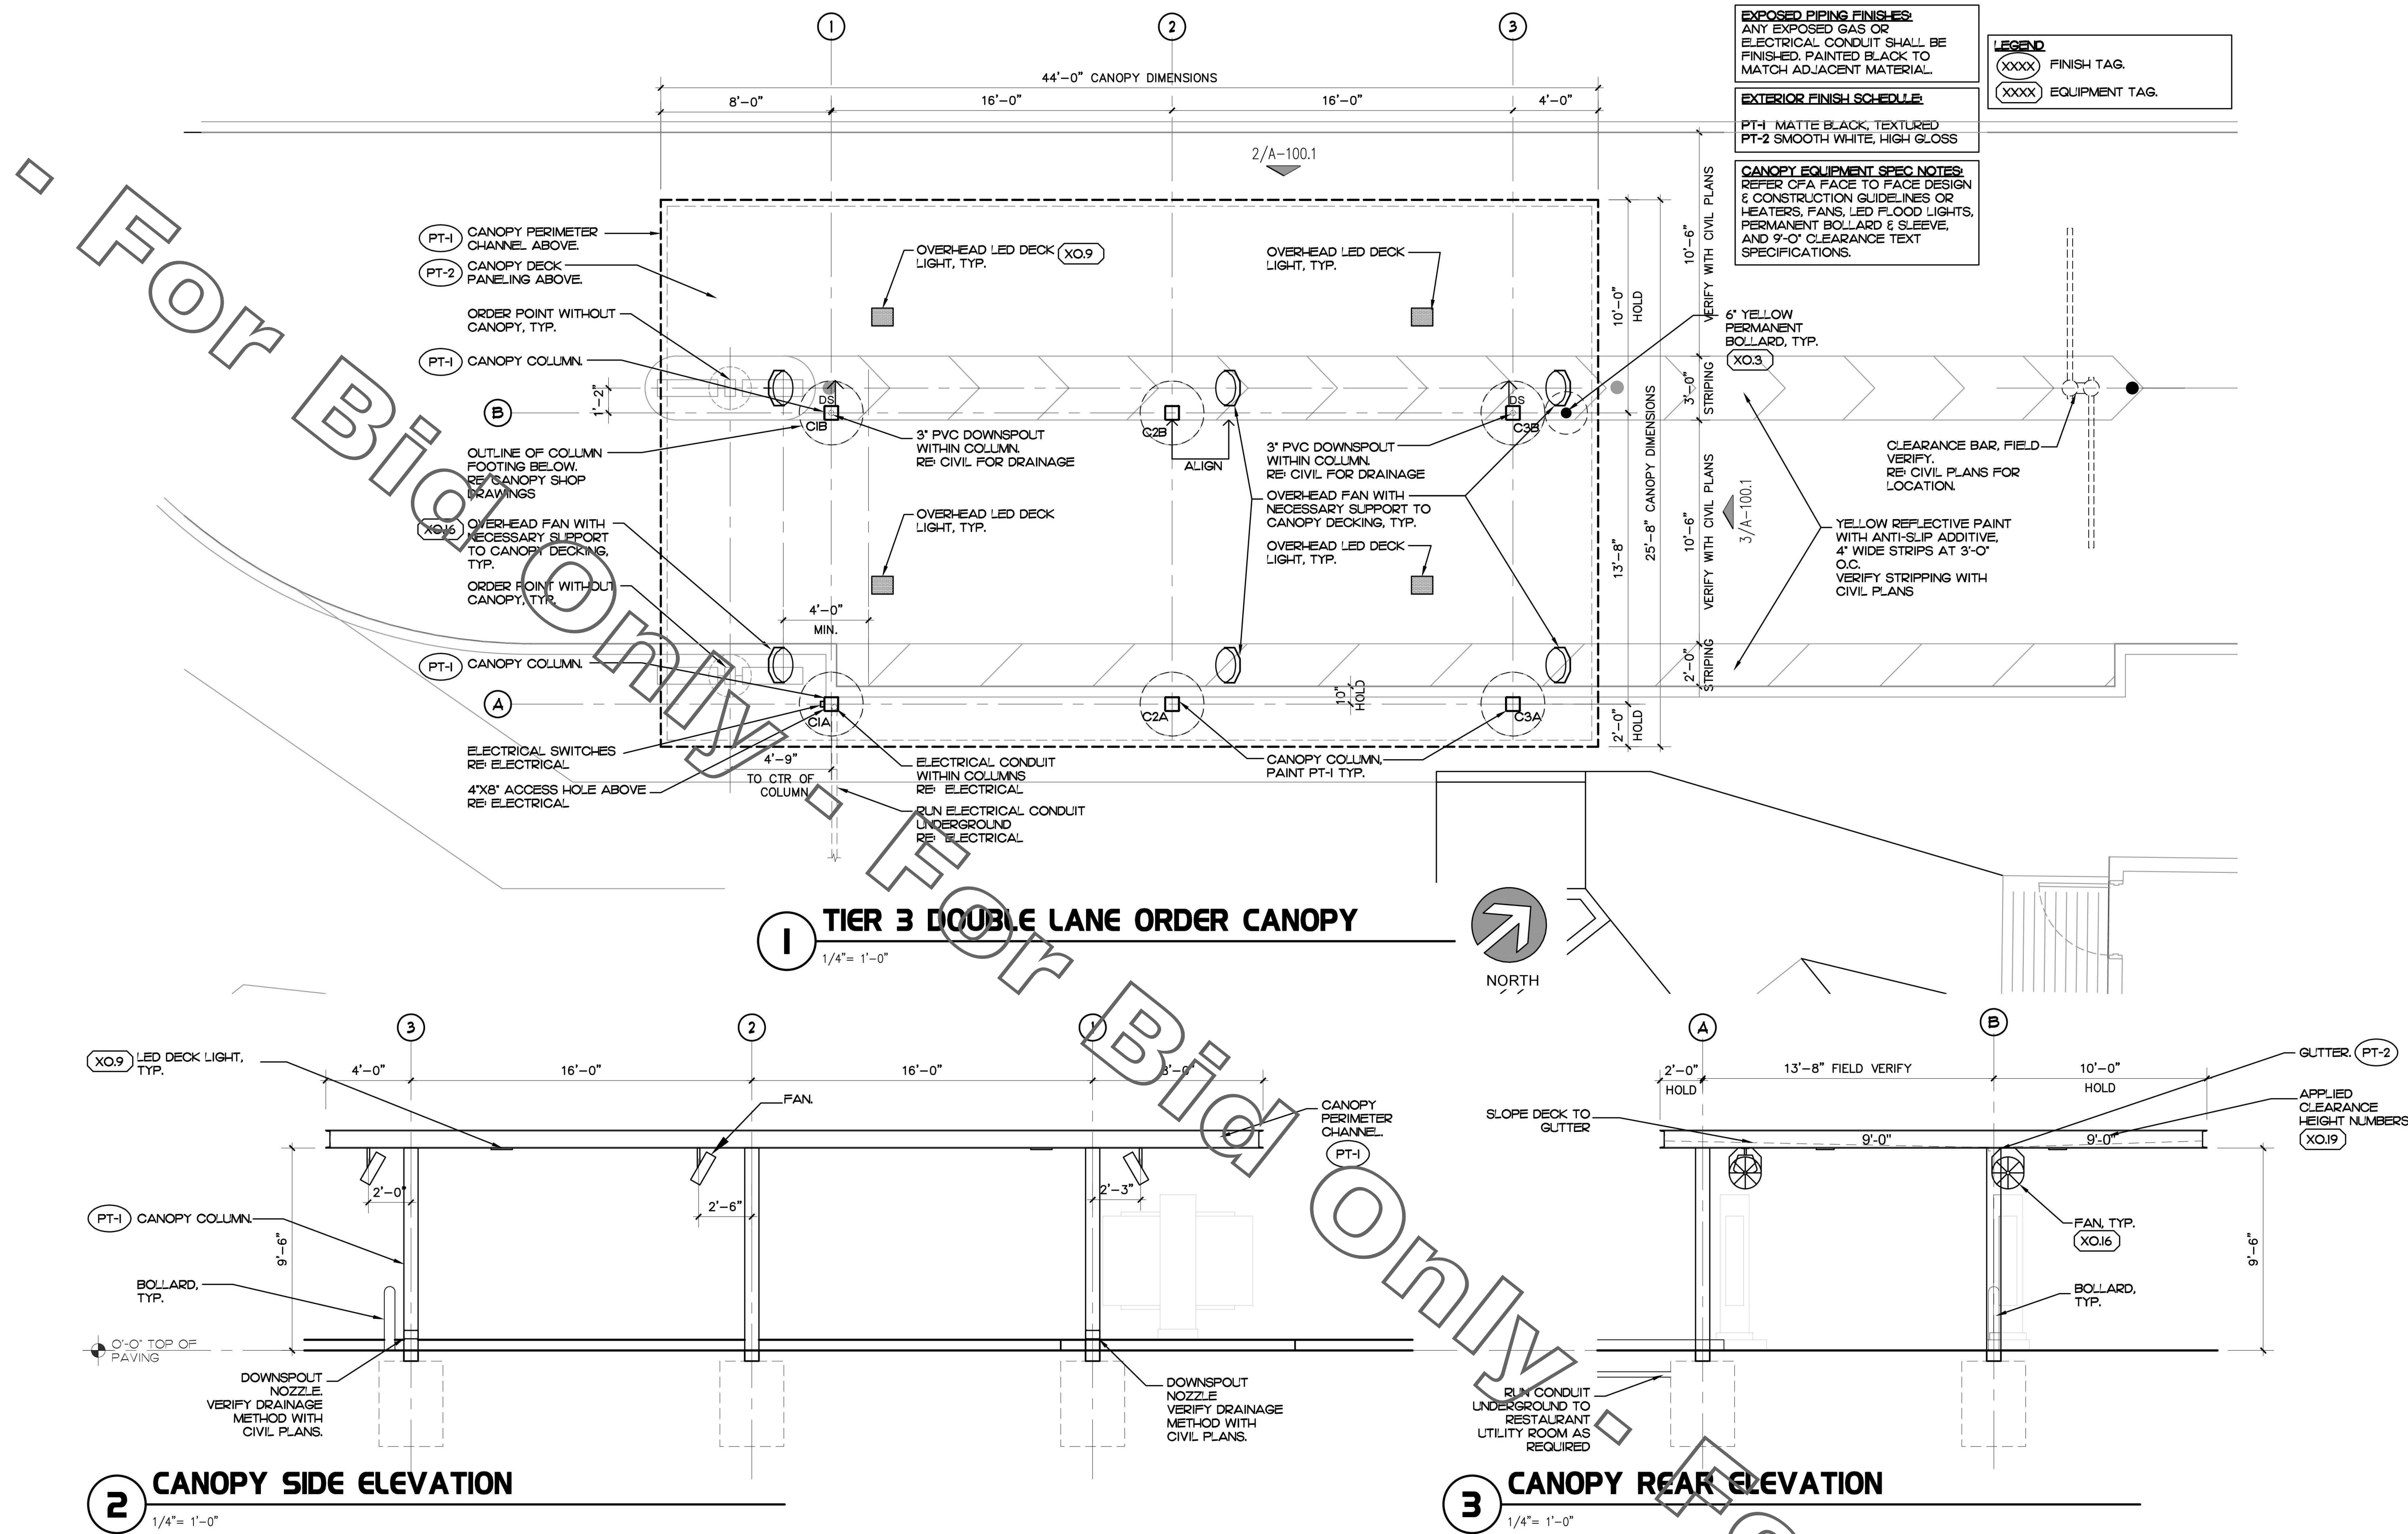

| EQUIPMENT SCHEDULE | | | | | | |
|--------------------|------------------------|--------------------|---|---------------------------------------|--|---|
| TAG | EQUIPMENT | SUPPLIER | CONTACT | MANUFACTURER | MODEL NUMBER | COMMENTS |
| XO.3 | BOLLARD SLEEVE | GC | - | INTERSTATE PRODUCTS OR APPROVED EQUAL | 1736YRS - EAGLE 6' | <ul style="list-style-type: none">6-7/8" ID, 7-3/8" OD, 56' H, COLOR: SAFETY YELLOW W/ REFLECTIVE RED STRIPE.HIGH DENSITY POLYETHYLENE (HDPE) CONSTRUCTION WITH UV INHIBITORS, SLIDE-ON & TRIM PER MANUFACTURER'S INSTALLATION INSTRUCTIONS. |
| XO.9 | LED DECK LIGHT | LANE | LARRY TOLBERT (704) 545-7615 L.TOLBERT@LANESUPPLYINC.COM | LSI | LEGACY LED CANOPY LIGHT CRUS SC LED LW 30 LE WHIT | <ul style="list-style-type: none">OVER-HEAD LED LIGHT PREMOUNTED TO CANOPY PER MANUFACTURER'S GUIDELINES.10-15/16" X 15-15/16" X 7-1/8", STANDARD SYMMETRIC LIGHT DISTRIBUTION, 300K LIGHT TEMPERATURE, GC RESPONSIBLE FOR ELECTRICAL CONNECTIONS |
| XO.16 | MOUNTED FAN | TOM BARROW COMPANY | SCOTT GEORGE (404) 351-0101 S.GEORGE@TOMBARROW.COM | TRI CORP | 18CAC-LITE | <ul style="list-style-type: none">18" DIA. FAN, STAINLESS STEEL OR BLACK FINISH, ALUMINUM BLADE, 10' CORD, TOTALLY ENCLOSED, CORROSION AND DENT PROOF HOUSING.120V, 1-PHASE, 3-SPEED MOTOR, MOUNT TO WALLS, COLUMNS OR CANOPY CEILING PER MANUFACTURER'S INSTRUCTIONS |
| XO.19 | CLEARANCE TEXT | LANE | LARRY TOLBERT (704) 545-7615 L.TOLBERT@LANESUPPLYINC.COM | CHANDLER SIGNS | - | <ul style="list-style-type: none">9'-0" CLEARANCE TEXT, 0.125" THK. ALUM. CAD CUT NUMBERS, PAINT CROSS OVERS TO MATCH CANOPY.TEXT HEIGHTS VARY BY CANOPY - SEE SHOPS FOR COMPONENT AND DIMENSION INFO, CANOPY VENDOR TO INSTALL ON ORDER POINT CANOPIES PER DRAWINGS. |
| XO.20 | RECEPTACLE OUTLET | GEXPRO | NEW STORE / REINVESTMENT BRIAN REECE (770) 840-4162 BRIANRECE@GEXPRO.COM | COOPER / ARROW-HART OR APPROVED EQUAL | VG620 | <ul style="list-style-type: none">DUPLEX GFCI RECEPTACLE OUTLET, RATED 120 VOLT, 20 AMP.419 X 130 X 120, MATERIAL: NON PLASTIC, COLOR: BLACK (PREFERRED) OR GRAY (ALTERNATE) |
| XO.21 | RECEPTACLE COVER PLATE | | | HUBBEL / KELLEMS OR APPROVED EQUAL | WP26E | <ul style="list-style-type: none">612 X 337 X 35, MATERIAL: HEAVY DUTY DIE-CAST ALUMINUM, SINGLE GANG BOX.COLOR: GRAY (TO BE FIELD PAINTED BLACK, TEXTURED, RUSTO, ELM#720830), INSTALL AT EXTENSION RING FOR PHOTOCELL AND ON ANY RECEPTACLE EXPOSED TO THE ELEMENTS. |
| XO.26 | SWITCH | | | HUBBEL / RACO OR APPROVED EQUAL | AH1221 | <ul style="list-style-type: none">SINGLE-POLE SWITCH INSTALLED AT CANOPY SWITCH BOX TO CONTROL LIGHTS, FANS, AND INFRARED HEATERS.RATED 120 VOLT, 20 AMP, MATERIAL: NYLON PLASTIC, COLOR: BLACK (PREFERRED) OR GRAY (ALTERNATE) |
| XO.27 | DELINEATOR | GORILLA POST | - | GORILLA POST | - | <ul style="list-style-type: none">DELINEATOR WITH SPRING AND 6" DIAMETER MAGNETIC BASE, INSTALLED AT MEAL DELIVERY AREA.2-1/3" DIA X 45" TUBE WITH BLACK CAP, MATERIAL: PLASTIC, COLOR: YELLOW OR BLACK. |



Chick-fil-A

Chick-fil-A
5200 Buffington Road
Atlanta, Georgia 30349-2998

INTERPLAN

ARCHITECTURE
ENGINEERING
INTERIOR DESIGN
PROJECT MANAGEMENT

AA 003420
CA 8660

604 COURTLAND STREET
SUITE 100
ORLANDO, FLORIDA 32804
PH 407.645.5008
FX 407.629.9124

SEAL:
THIS DOCUMENT IS NOT FOR CONSTRUCTION
UNLESS THE ARCHITECT OR ENGINEER'S
SIGNATURE AND SEAL APPEAR BELOW

CHICK-FIL-A
SAR Stanford Station FSR
900 W 23rd St
Panama City, FL 32405

FSR#00781

BUILDING TYPE / SIZE: P12 SE LRG
RELEASE: V2_18.01

REVISION SCHEDULE
NO. DATE DESCRIPTION

ARCHITECT'S PROJECT # 2017.0691
PRINTED FOR: BID

DATE: February 15, 2018
DRAWN BY: JF

Information contained on this drawing and in all digital files
produced for this project may not be reproduced or
any manner without express written or verbal consent from
the architect or engineer.

SHEET
ARCHITECTURAL SITE
PLAN - F2F

SHEET NUMBER
A-100.1