



PANDA RESTAURANT GROUP INC.
1683 Walnut Grove Ave.
Rosemead, California
91770
Telephone: 626.799.9898
Facsimile: 626.372.8288

All ideas, designs, arrangement and plans indicated or represented by this drawing are the property of Panda Express Inc. and were created for use on this specific project. None of these ideas, designs, arrangements or plans may be used by or disclosed to any person, firm, or corporation without the written permission of Panda Express Inc.

REVISIONS:	

ISSUE DATE:	
1	02.09.2021 ISSUE FOR PERMIT
2	04.22.2021 ISSUE FOR BID

DRAWN BY: JEL

PANDA PROJECT #: - S8-21-D8101
C&P PROJECT #: - 2210016



Cuhaci & Peterson
Architects Engineers Planners

2600 Maitland Center Pkwy, Maitland, FL 32751
P (407) 661-9100
F (407) 661-9101
www.cuhaci.com
Florida Corporate Certificate #AA 130628

04.22.2021

NORTH CAROLINA
PROFESSIONAL
SEAL
041891
ENGINEER
JASON P. MORAS


PANDA EXPRESS

TRUE WARM AND WELCOME 2300
3101 RAEFORD ROAD
FAYETTEVILLE, NC 28303

E-101.1

CANOPY LIGHTING PLAN

TRUE WARM & WELCOME 2300 R4

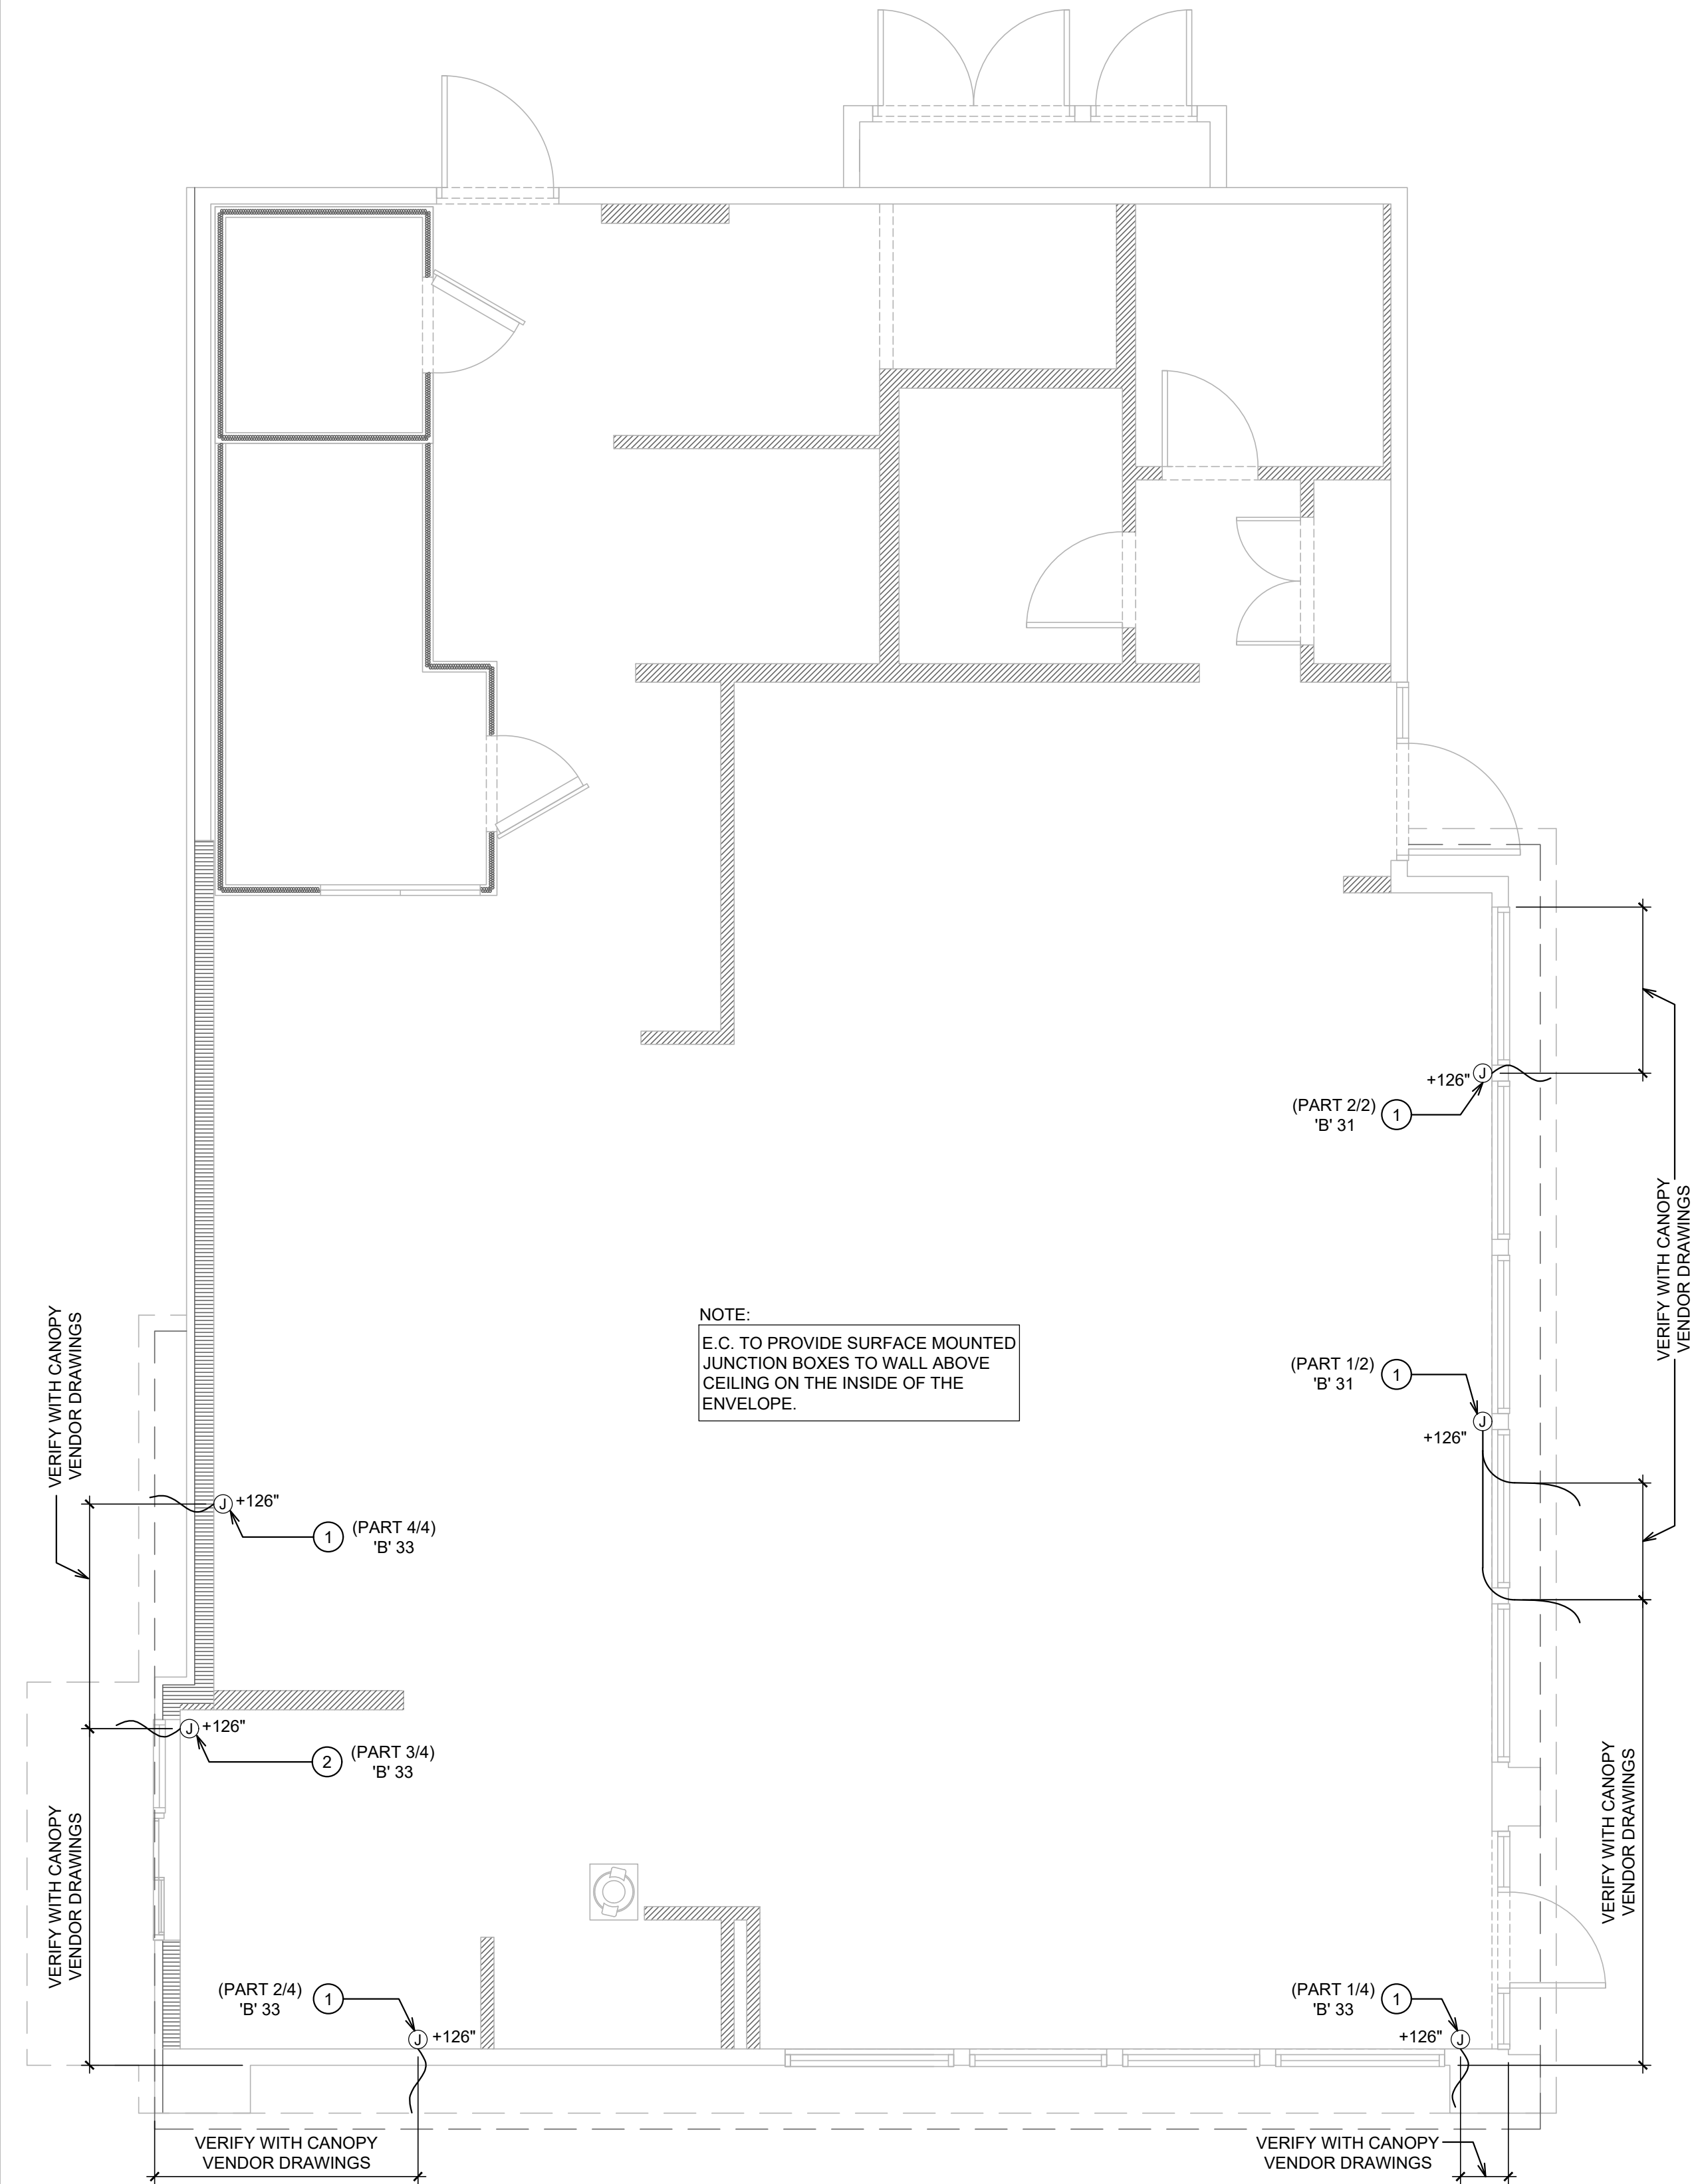

1. E.C. TO PROVIDE J-BOX WITH 3' WHIP FOR CONNECTION TO PANDA EXPRESS PROVIDED LIGHTED CANOPY. E.C. TO MAKE FINAL CONNECTION.	
2. E.C. TO PROVIDE J-BOX WITH 3' WHIP FOR CONNECTION TO PANDA EXPRESS PROVIDED LIGHTED DRIVE THRU CANOPY. E.C. TO MAKE FINAL CONNECTION.	
3. ALL JUNCTION BOXES ON THIS SHEET TO BE RECESS MOUNTED.	
#	CANOPY LIGHTING KEYED NOTES
2	
NOT TO SCALE	
E-101.1	

CANOPY LIGHTING PLAN	
1	
Scale: 1/4"=1'-0"	
E-101.1	