


LIGHTING FIXTURE SCHEDULE			PROVIDED FOR INFORMATION ONLY. VERIFY AND INSTALL PER ELECTRICAL DRAWING			02-13-17
ITEM	SYMBOL	DESCRIPTION	QTY.	MFR. □ CAT. NO.	REMARK	
INTERIOR LIGHTING ITEM						
L1		RECESSED MOUNTED FLAT PANEL LED 2' X 4' TROFFER, 3500K	REFER TO ELECTRICAL SHEET E-001 FOR LIGHTING FIXTURE QUANTITY	LSI FIXTURE: ELFP24-LED-35-UE	FURNISHED BY OWNER INSTALLED BY GC	
L1EM		RECESSED MOUNTED FLAT PANEL LED 2' X 4' TROFFER, 3500K, EMERGENCY BATTERY		LSI FIXTURE: ELFP24-LED-35-UE-EM	FURNISHED BY OWNER INSTALLED BY GC	
L2		RECESSED MOUNTED FLAT PANEL LED 2' X 2' TROFFER, 3500K, EMERGENCY BATTERY		LSI FIXTURE: ELFP22-LED-35-UE-EM	FURNISHED BY OWNER INSTALLED BY GC	
L4		UNIVERSAL MOUNT LED EXIT SIGN WITH BATTERY PACK, 2 FACE, GREEN LETTER		EXITRONIX FIXTURE: GVEX-U-BP-WB-BL-R6	FURNISHED BY OWNER, INSTALLED BY GC	
L6A		HOOD LIGHT		FURNISHED & INSTALLED BY EQUIPMENT SUPPLIER	LIGHTS SUPPLIED & PRE-WIRED BY HOOD VENDOR. ELEC. CONTRACTOR TO CONNECT MAIN WIRES TO SHUNT TRIP BREAKER AND HOOD CONTROL PANEL	
L6B		WALK-IN COOLER FLUORESCENT LIGHT, 48"		KASON FIXTURE: 18180F00048	FURNISHED BY WIC VENDOR, G.R.E., INSTALLED BY GC	
L19		DOWN LIGHT, RECESSED IN CEILING		ELITE HOUSING: LD6IC-AT LED MODULE: RL607-750L-DIMTR-120-30K-FL-SN-SN	FURNISHED BY OWNER, INSTALLED BY GC	
L19EM		EMERGENCY DOWN LIGHT, RECESSED IN CEILING		ELITE HOUSING: LD6IC-AT LED MODULE: RL607-750L-DIMTR-120-30K-FL-SN-SN	EMERGENCY RECESSED DOWN LIGHT - NORMALLY ON FURNISHED BY OWNER INSTALLED BY GC	
L20		3-3/4" APERTURE ADJUSTABLE ELBOW LYTECASTER RECESSED DOWNLIGHT		LIGHTOLIER FRAME-IN KIT: 302MRSPX REFLECTOR TRIM: 378WHX BULB: LED5.5DMR1683035	FURNISHED BY OWNER, INSTALLED BY GC	
L26		DECORATIVE PENDANT LIGHT		CASEY ARCHITECTURAL LIGHTING (2) A_ROUND: PE-RND, (2) B_ONION: PE-ONI (2) C_OBLONG: PE-OBL, (2) D_BARREL:PE-BAR BULB: ST-64 CLEAR #41098	FURNISHED BY OWNER, INSTALLED BY GC. REFER TO RCP FOR HEIGHT.	
L30		WHITE LED MODULES MOUNTED IN SOFFIT	ZLED LIGHTING FIXTURE: MOD-R-5050-WW	FURNISHED BY OWNER, INSTALLED BY GC		
L35		9.8" DIA. DECORATIVE ISLA PENDANT	LBL LIGHTING FIXTURE: LF512CRSC BULB: ST-64 CLEAR #41098	FURNISHED BY OWNER, INSTALLED BY GC. REFER TO RCP FOR HEIGHT.		
L100		110 WATT MINI INVERTER RATED FOR 90 MIN.	EELP FIXTURE: PS-110-HP-S	FURNISHED BY OWNER, INSTALLED BY GC		
L101		110 WATT MINI INVERTER RATED FOR 90 MIN.	EELP FIXTURE: PS-110-HP-S	FURNISHED BY OWNER, INSTALLED BY GC (VERIFY EXACT INVERTER WITH VILLA LIGHTING)		
NIGHT LIGHTING REQUIREMENTS: "NL" DESIGNATION INDICATED NIGHT LIGHT ON UNSWITCED CIRCUIT. 1. ONE NL BY SERVICE COUNTER, POS / CASHIER 2. ONE NL BY POS / CASHIER AT DRIVE THRU STATION IF APPLICABLE 3. ONE NL BY EACH EXIT DOORS IN DINNING ROOM □ BACK OF HOUSE 4. ONE NL BY MANAGER STATION						
EXTERIOR LIGHTING						
L85A		LED WALL SCONCE MOUNTED OVER DOOR	REFER TO ELECTRICAL SHEET E-001 FOR LIGHTING FIXTURE QUANTITY	HOWARD LIGHTING FIXTURE: VL20	FURNISHED BY OWNER, INSTALLED BY GC, REFER TO ARCHITECTURAL ELEVATION	
L86		REMOTE LED EMERGENCY EGRESS LIGHT		MLED1-G-WP	10'-0" AFF, FURNISHED BY OWNER, INSTALLED BY GC	
L86A		RECESSED EMERGENCY LIGHT UNDER RED ENTRANCE PORTAL		ELITE HOUSING: LD6IC-AT LED MODULE: RL607-750L-DIMTR-120-30K-FL-SN-SN	NORMALLY ON, FURNISHED BY OWNER INSTALLED BY GC	
L90		DECORATIVE WALL SCONCE		HINKLEY LIGHTING FIXTURE: ATLANTIS 1644BZ-LED BULB: LED5.5DMR1683035	FURNISHED BY OWNER, INSTALLED BY GC	
CEILING SCHEDULE						
INSTALLED AND FURNISHED BY: G.C. UNLESS NOTED OTHERWISE						
NO	MANUFACTURER	DESCRIPTION	MATERIAL	FINISH		
C1	ARMSTRONG	2' X 2' SUSPENDED T-BAR GRID CEILING SYSTEM	CUSTOM #PN91311	T-BAR AND GRID COLOR: SEPIA CONTACT AT ARMSTRONG - SHERRY BRUNT 1-800-442-4212		
C2	USG	2' X 4' SUSPENDED T-BAR GRID CEILING SYSTEM	"VINYL ROCK" VINYL CLAD GYP. BD PANELS	SMOOTH AND WASHABLE WHITE		
C3	GOLD BOND	MONOLITHIC CEILING ON METAL FRAMING	5/8" GYP. BD.	SMOOTH PAINT - WHITE AND WASHABLE		
SEE SHEET A-103 FOR PAINT SCHEDULE						
				<div>NOTE: PROVIDE 4 VERTICAL WIRES (ATTACHED TO MAIN RUNNERS) WITHIN 3" OF EACH CORNER OF EACH FIXTURE. #8 GA. MIN HANGER WIRE @ OPP. CORNER FOR FIXT. WEIGHING LESS THAN 56 LBS. LATERAL BRACING SEE DETAIL 13 / A-403 LIGHT FIXTURE SEE "E" DWGS FOR SPECS. PROVIDE SCREWS OR CLIPS & FASTEN FIXT. TO T-BAR HANGER WIRE SEE 13/A-403</div>		
NOT USED		3	LIGHT FIXTURE DETAIL		2	
Scale= NTS		A-105	Scale= NTS		A-105	

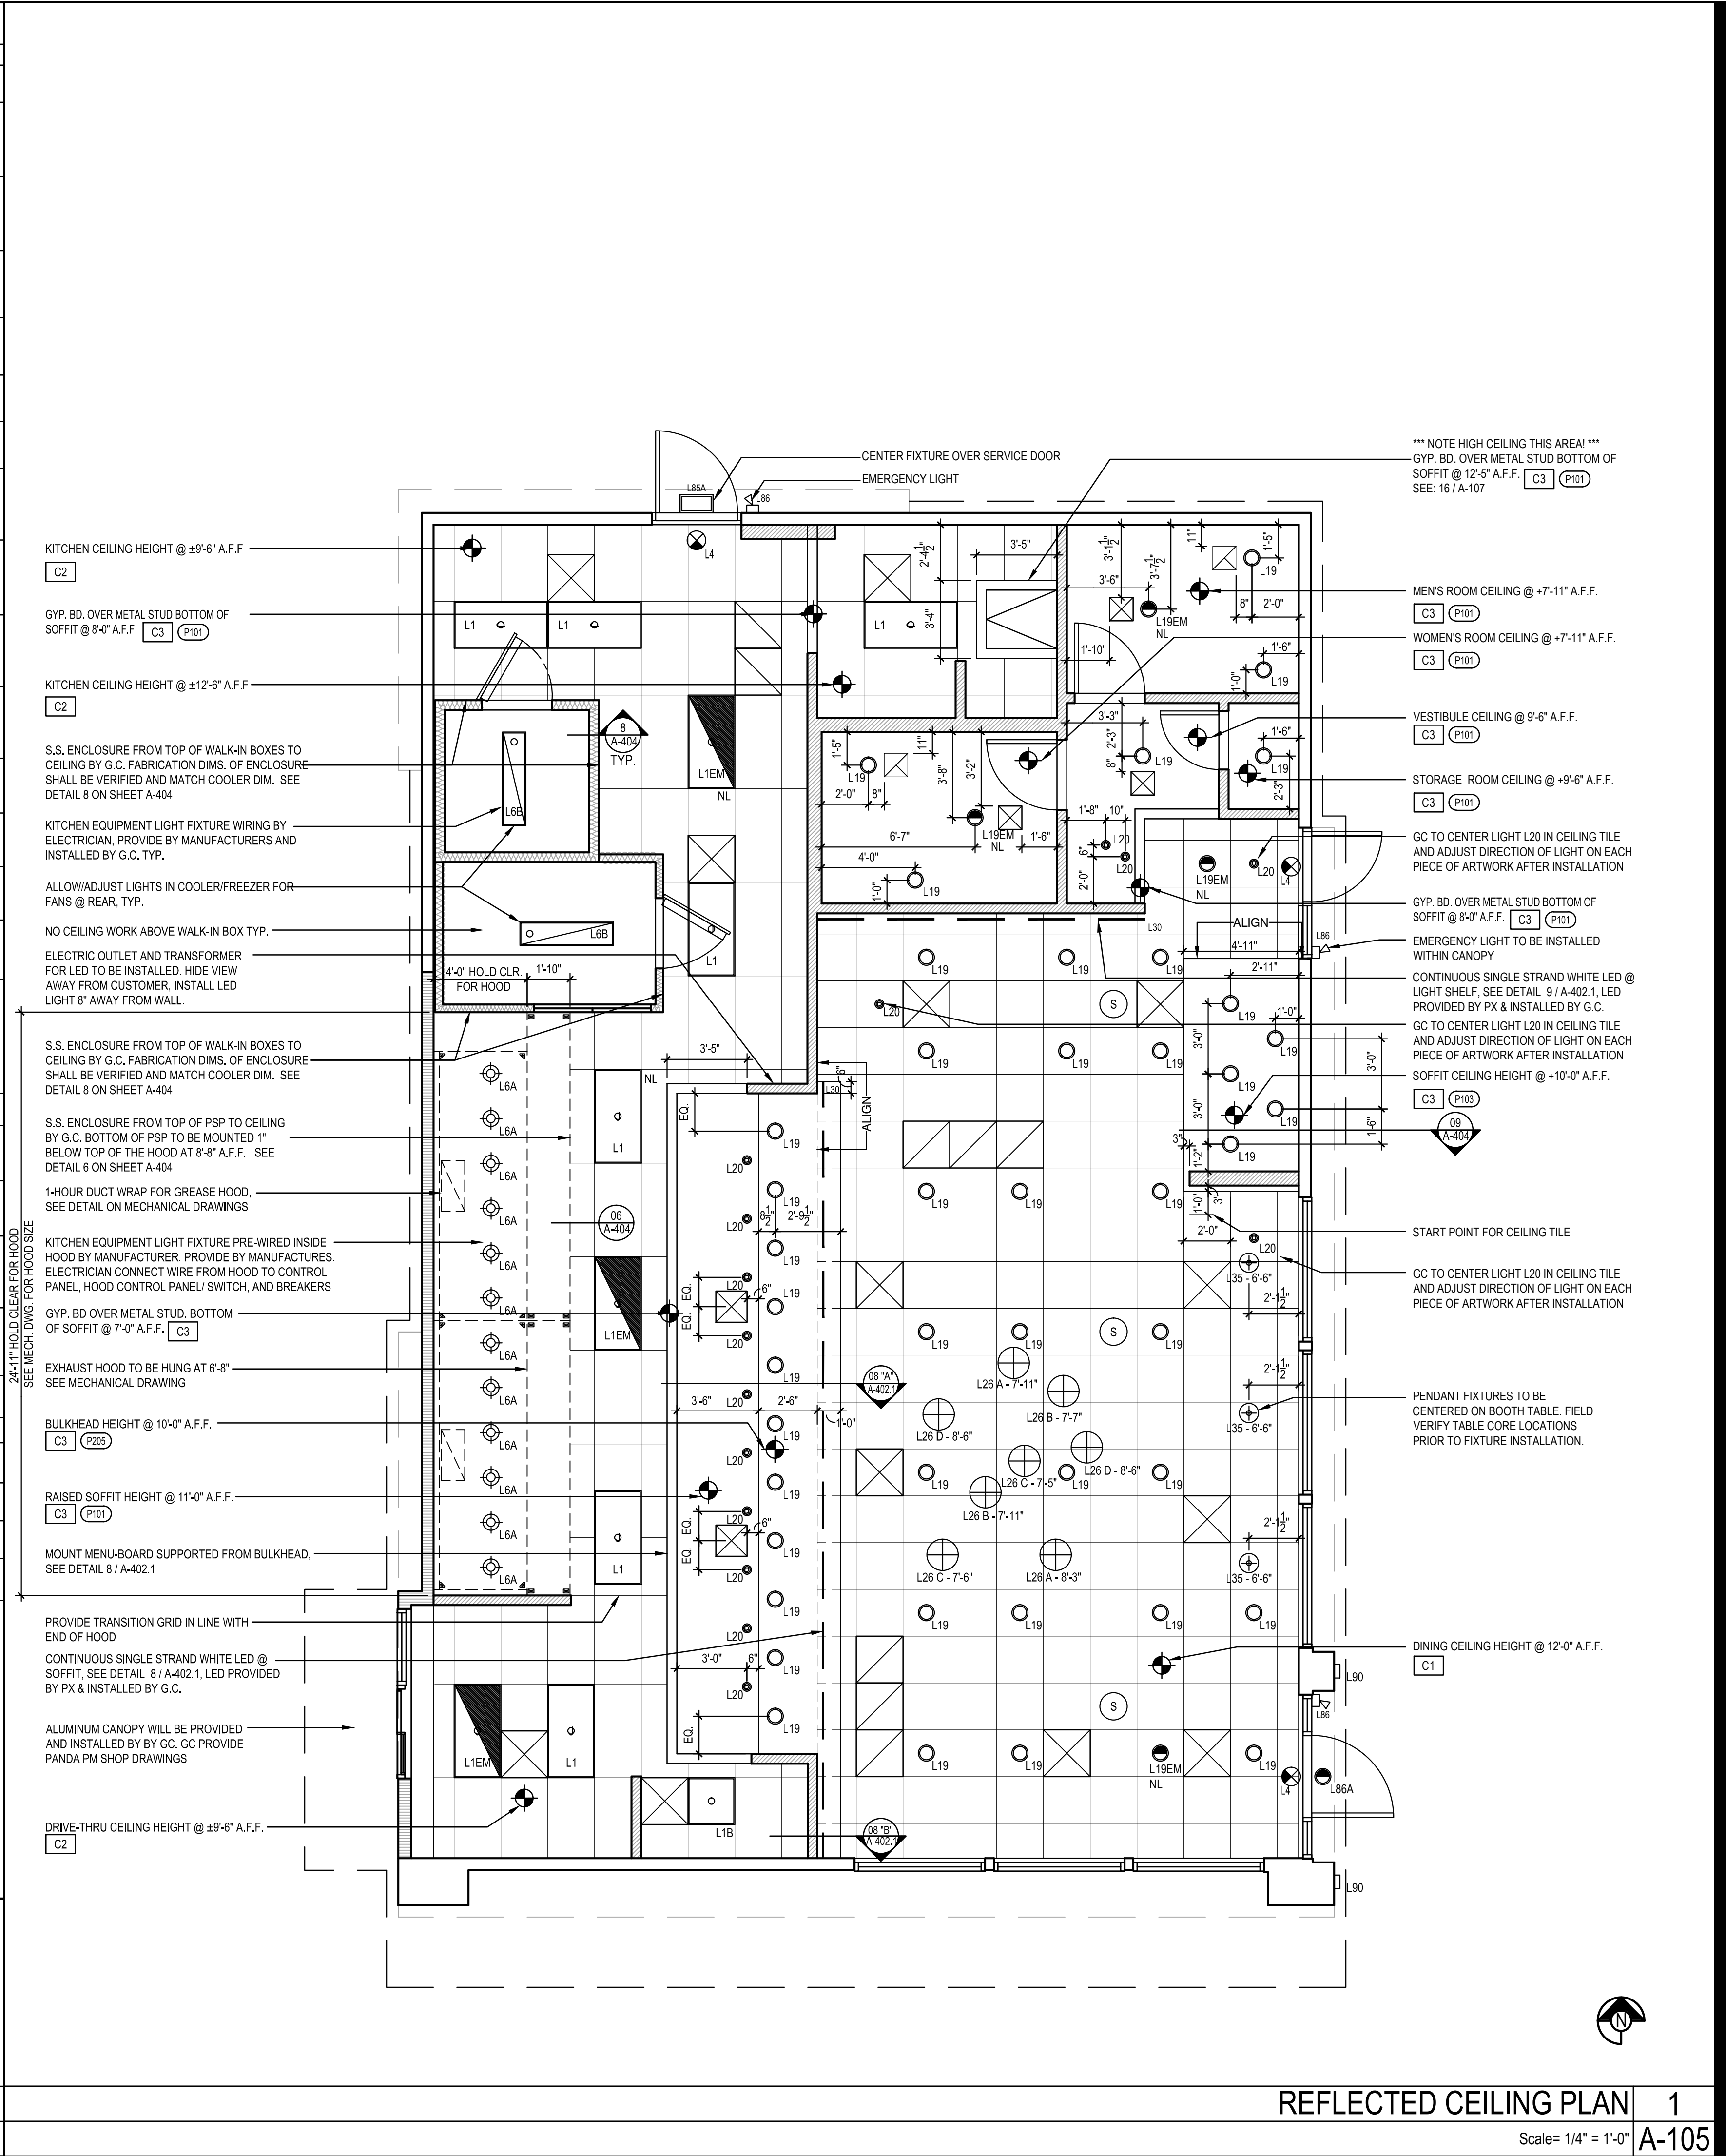

PANDA RESTAURANT GROUP INC.
1683 Walnut Grove Ave.
Rosemead, California
91770
Telephone: 626.799.9898
Facsimile: 626.372.8288

All ideas, designs, arrangement and plans indicated or represented by this drawing are the property of Panda Express Inc. and were created for use on this specific project. None of these ideas, designs, arrangements or plans may be used by or disclosed to any person, firm, or corporation without the written permission of Panda Express Inc.

REVISIONS:

ISSUE DATE:

1st	ISSUE FOR PERMIT	02-15-17
2nd	ISSUE FOR BID	02-22-17

DRAWN BY: RR

PANDA PROJECT #: S8-17-D4968
ARCH PROJECT #: 1703

RANDY REYNOLDS
ARCHITECT

1702 MILDARE COURT - THOMPSONS STATION, TN 37179
PHONE (615) 981-0675 □ FAX (866) 584-1225

STATE OF GEORGIA
Randy Reynolds
REGISTERED ARCHITECT
EXPIRATION DATE 02/01/2018
17

PANDA EXPRESS
Terraces at Suwanee Gateway (in front of Lowe's)
3276 LAWRENCEVILLE-SUWANEE RD
SUWANEE, GA
2200 TRUE WARM & WELCOME

A-105
REFLECTED CEILING PLAN