


GENERAL CEILING NOTES:

1. GENERAL CONTRACTOR SHALL NOTIFY ARCHITECT OF ANY PROBLEMS WITH CEILING HEIGHTS OR LIGHT FIXTURES BEFORE FINISH CEILINGS ARE INSTALLED. IF THE CONTRACTOR FAILS TO DO SO, HE SHALL BE RESPONSIBLE FOR TAKING DOWN THE CEILING & LIGHT FIXTURES AND REINSTALLING THEM IN A CONFIGURATION ACCEPTABLE TO THE ARCHITECT AT NO ADDITIONAL COST.
2. COORDINATE WORK WITH OTHER TRADES HAVING WORK IN THE CEILING INCLUDING, BUT NOT LIMITED TO: TELEPHONE, SECURITY, CABLE COMPANIES WHEREVER THEIR RESPECTIVE WORK IS CONTIGUOUS.
3. PROVIDE CUTOUT AND OTHER SPECIAL PROVISIONS IN ACOUSTICAL WORK AS REQUIRED FOR LIGHTING FIXTURES, REGISTERS, DIFFUSERS, AND OTHER INSERTED ITEMS.
4. ALL MATERIALS SHALL HAVE CLASS 1 FLAME SPREAD RATING AND BE INSTALLED IN ACCORDANCE WITH MANUFACTURER'S WRITTEN SPECIFICATIONS AND CODES.
5. ALL JOINTS IN THE TILE SHALL BE SQUARE, LEVEL AND ALIGNED WITH EACH OTHER.
6. ALL CEILING FIXTURES, EXIT SIGNS, SPEAKERS, ETC., SHALL BE CENTERED IN CEILING TILE, UNLESS NOTED OTHERWISE.
7. SEE ENGINEERS' DRAWINGS FOR LIGHTING AND MECHANICAL LAYOUTS. CONTRACTOR SHALL NOTIFY ARCHITECT IMMEDIATELY OF ANY DISCREPANCIES NOTED BETWEEN ARCHITECTURAL AND ENGINEERING DRAWINGS OR BETWEEN ENGINEERING DISCIPLINES. G.C. TO COORDINATE ALL DUCT DAMPERS TO BE REACH FROM ACCESSIBLE CEILINGS.
8. RECESSED CEILING SPEAKERS TO BE INSTALLED BY OWNERS VENDOR. GC COORDINATE.
9. DIMENSIONS SHOWN ON CEILING GRID PROVIDED TO LOCATE GRID AS SHOWN ON PLAN.

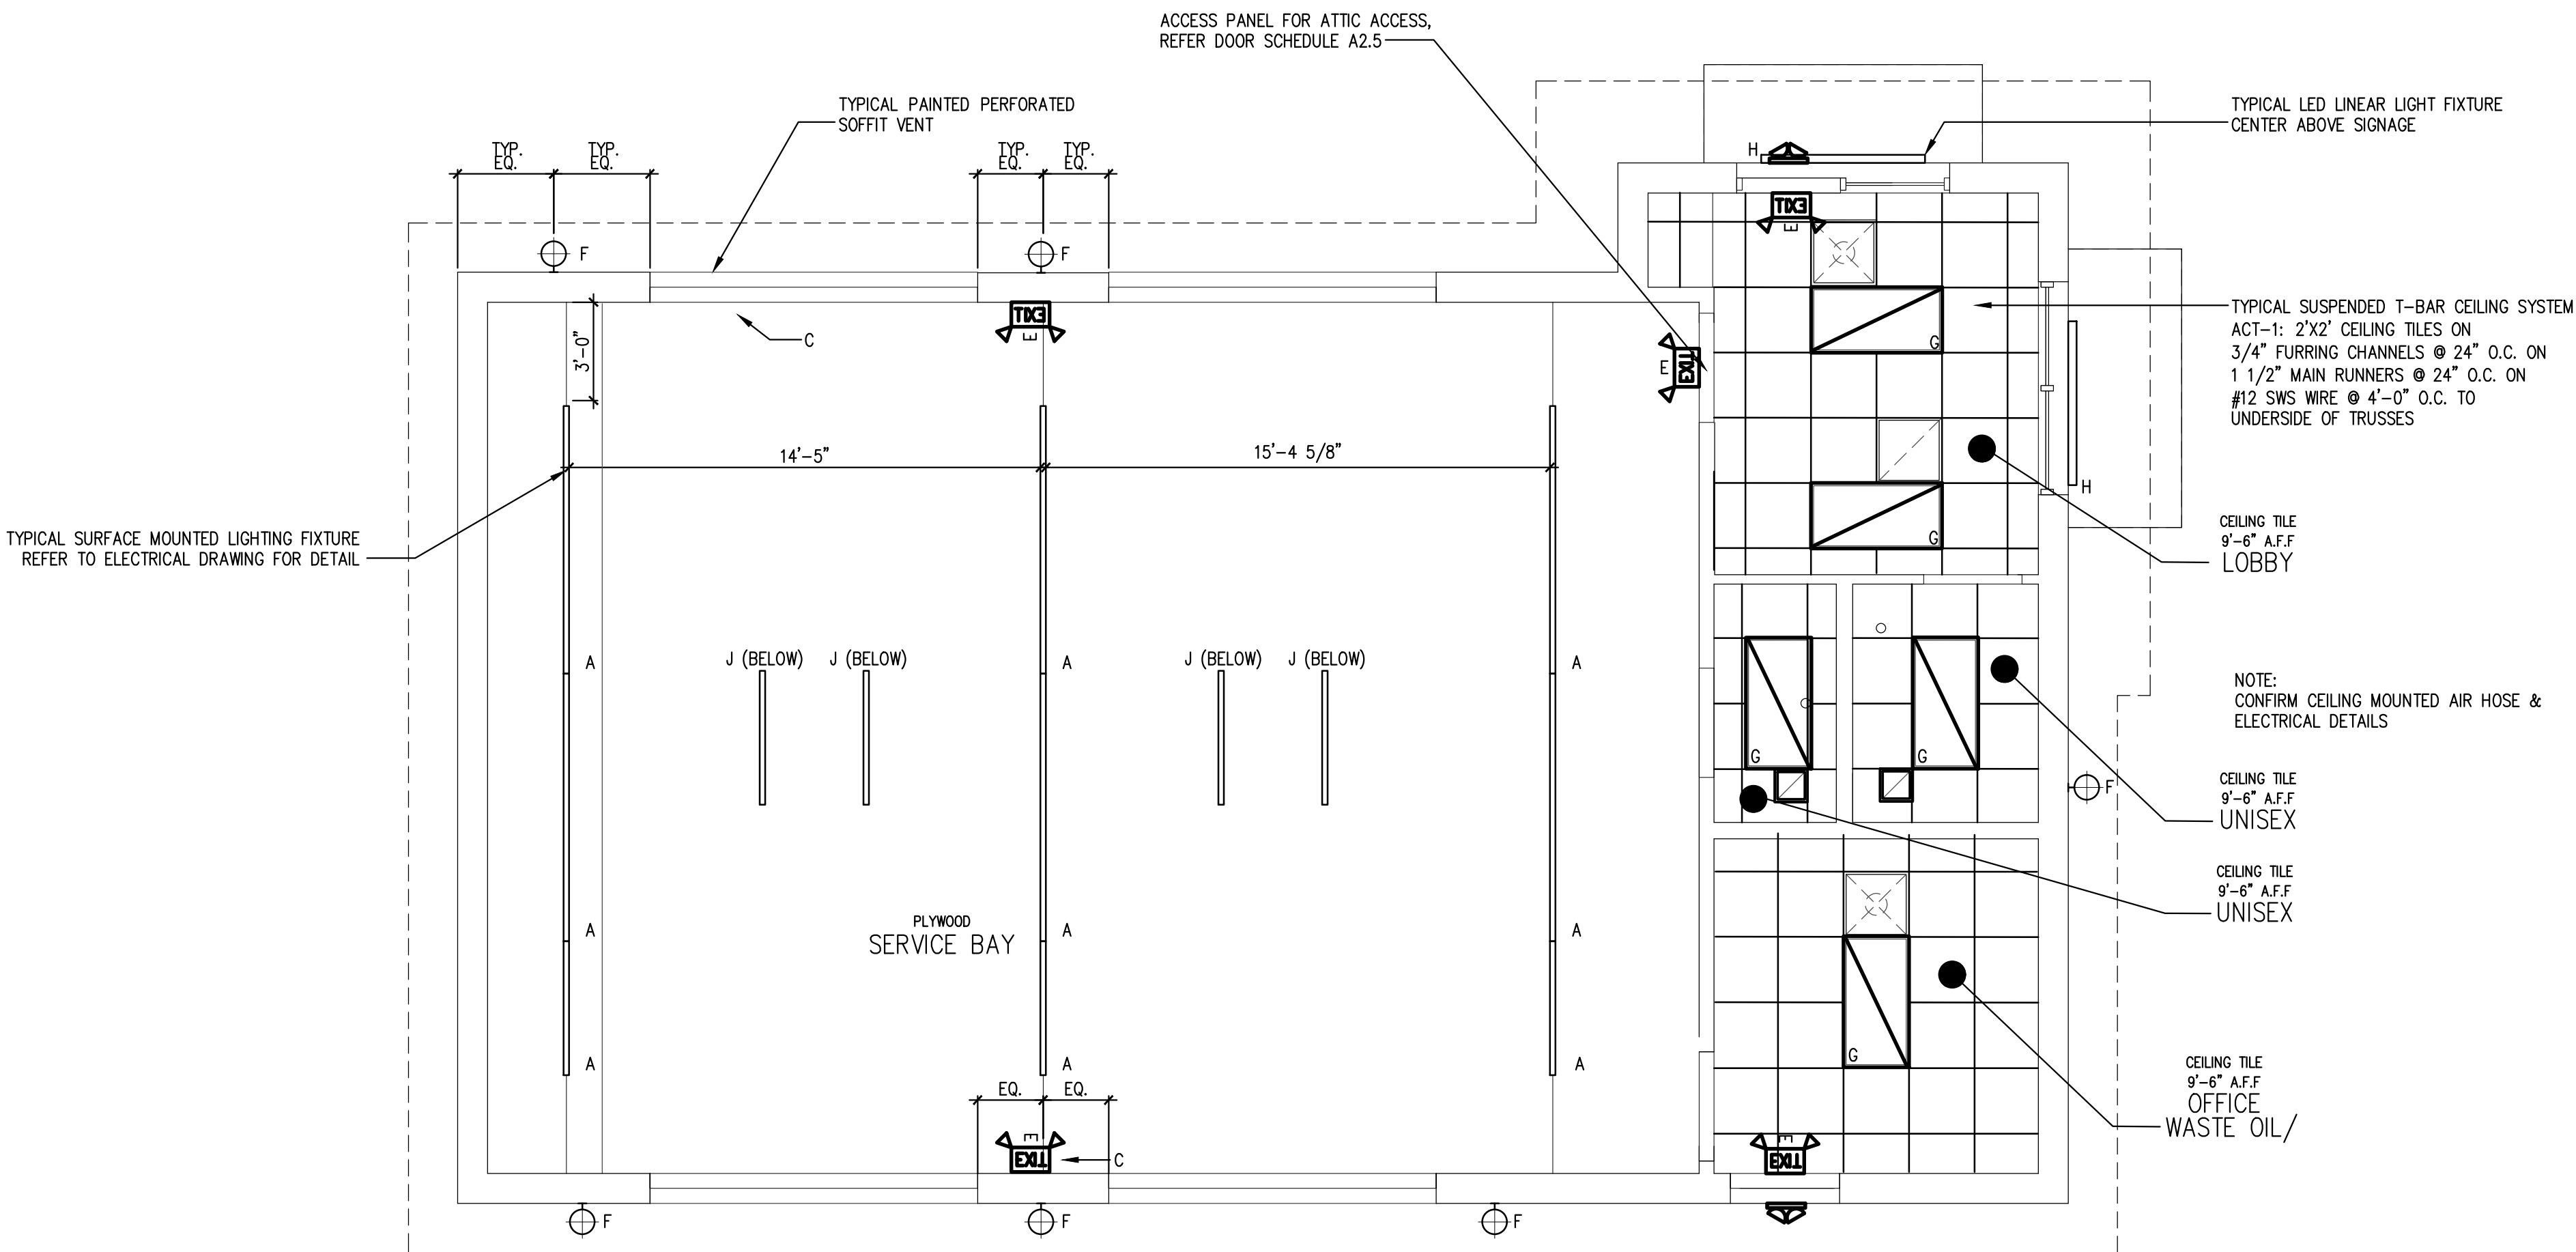

1

REFLECTED CEILING PLAN

SCALE: 1/4" = 1'-0"

ELECTRICAL LEGEND

- ELECTRICAL DUPLEX OUTLET
HEIGHT AS NOTED
- ELECTRICAL DUPLEX OUTLET - GFI
HEIGHT AS NOTED
- ELECTRICAL QUAD OUTLET - FLOOR
LOCATION AS DIMENSIONED
- JUNCTION BOX
HEIGHT AS NOTED
- THERMOSTAT
HEIGHT AS NOTED
- DATA LINE/COMM OUTLET
HEIGHT AS NOTED
- TELEPHONE OUTLET
HEIGHT AS NOTED
- ALARM PANEL
HEIGHT AS NOTED
- TELEVISION CABLE OUTLET
HEIGHT AS NOTED
- CENTRAL LIGHTING CONTROL PANEL
HEIGHT AS NOTED
- CEILING FAN LOCATION AS
DIMENSIONED
- CEILING MOUNTED SMOKE DETECTOR
HARD WIRED & INTERCONNECTED
WITH BATTERY BACKUP
- CEILING MOUNTED LIGHT FIXTURE - FLUSH
LOCATION AS DIMENSIONED
- SUSPENDED DECORATIVE LIGHT FIXTURE
OWNER SUPPLIED - CONTRACTOR INSTALLED
- WALL MOUNTED DECORATIVE FIXTURE
LOCATION AS DIMENSIONED
- CEILING MOUNTED WALL WASH - FLUSH
LOCATION AS DIMENSIONED
- WALL MOUNTED LIGHT SWITCH
HEIGHT AS NOTED
- WALL MOUNTED LIGHT DIMMER
HEIGHT AS NOTED
- HOSE BIB
HEIGHT AS NOTED
- GAS LINE SHUTOFF VALVE LOCATION TO
BE COORDINATED ON SITE. HEIGHT AS
NOTED
- SWITCH MTD. OCCUPANCY MOTION SENSOR
WITH AUTOMATIC SHUTOFF TO TURN LIGHTS
OFF WITHIN 30 MINUTES OF OCCUPANTS
LEAVING SPACE.
- CIRCUIT NUMBER

LIGHTING LEGEND

A	LED STRIPLIGHT FIXTURE LITHONIA LIGHTING:ZL1N - 48" 5000LM 40K LITHONIA LIGHTING:ZL1N - 96" 10000LM 40K
B	LED FLAT PANEL LIGHT EELP VFP6-B-24-50L-QT-40K
C	EMERGENCY EXIT LIGHT, INDOOR/OUTDOOR -2.78W HUBBELL - SERIES PG FINISH WHITE 120VAC WALL MOUNTED LIGHTING & BATTERY BACKUP. CONFIRM MOUNTING HEIGHT ON SITE.
D	BATHROOM EXHAUST - 30-110 CFM GREENHECK - SP-110
E	EXIT SIGN - 3.8W LITHONIA - ECBG LED M6 WITH BATTERY BACKUP. CONFIRM MOUNTING HEIGHT ON SITE. CENTER ABOVE OPENING U.N.O.
F	OUTDOOR LED WALLPACK WET SAFETY RATED - 9.78W - 3000K WLS LIGHTING: WLS-LMWC-1-N-8-T3-C MOUNTING HEIGHT 12'-0" A.F.F.
G	2X4 LED LIGHT FIXTURE
H	WALL MOUNTED LED LINEAR LIGHT FIXTURE SPI LIGHTING SEW 12146 8FT-L115W
J	LED LINEAR VAPOR LIGHT FIXTURE LITHONIA XML L48 5000LM 40K



JOHN FRANZ
architect

(817) 737-9922

4055 International Plaza Suite 100
Fort Worth, Texas 76109

STRICKLAND BROTHERS
3223 BATTLEGROUND AVE.
GREENSBORO, NC 27408

Revisions:

File Name: 21337 A1.3
Project No: 21337
Date: 12/17/21
Drawn By: TI
Checked By:

SHEET

A1.3

REFLECTED
CEILING PLAN